


Remove Wood Pole Light Std.

Sta. 736+70-29.6' Lt. 1 Ea.  
Sta. 738+19-29' Lt. 1 Ea.

FHWA REGION	STATE	FED. AID PROJ. NO.	SHEET NO.
8	N.D.	RRS-1-006(005)066	103

① Revised 1-18-91

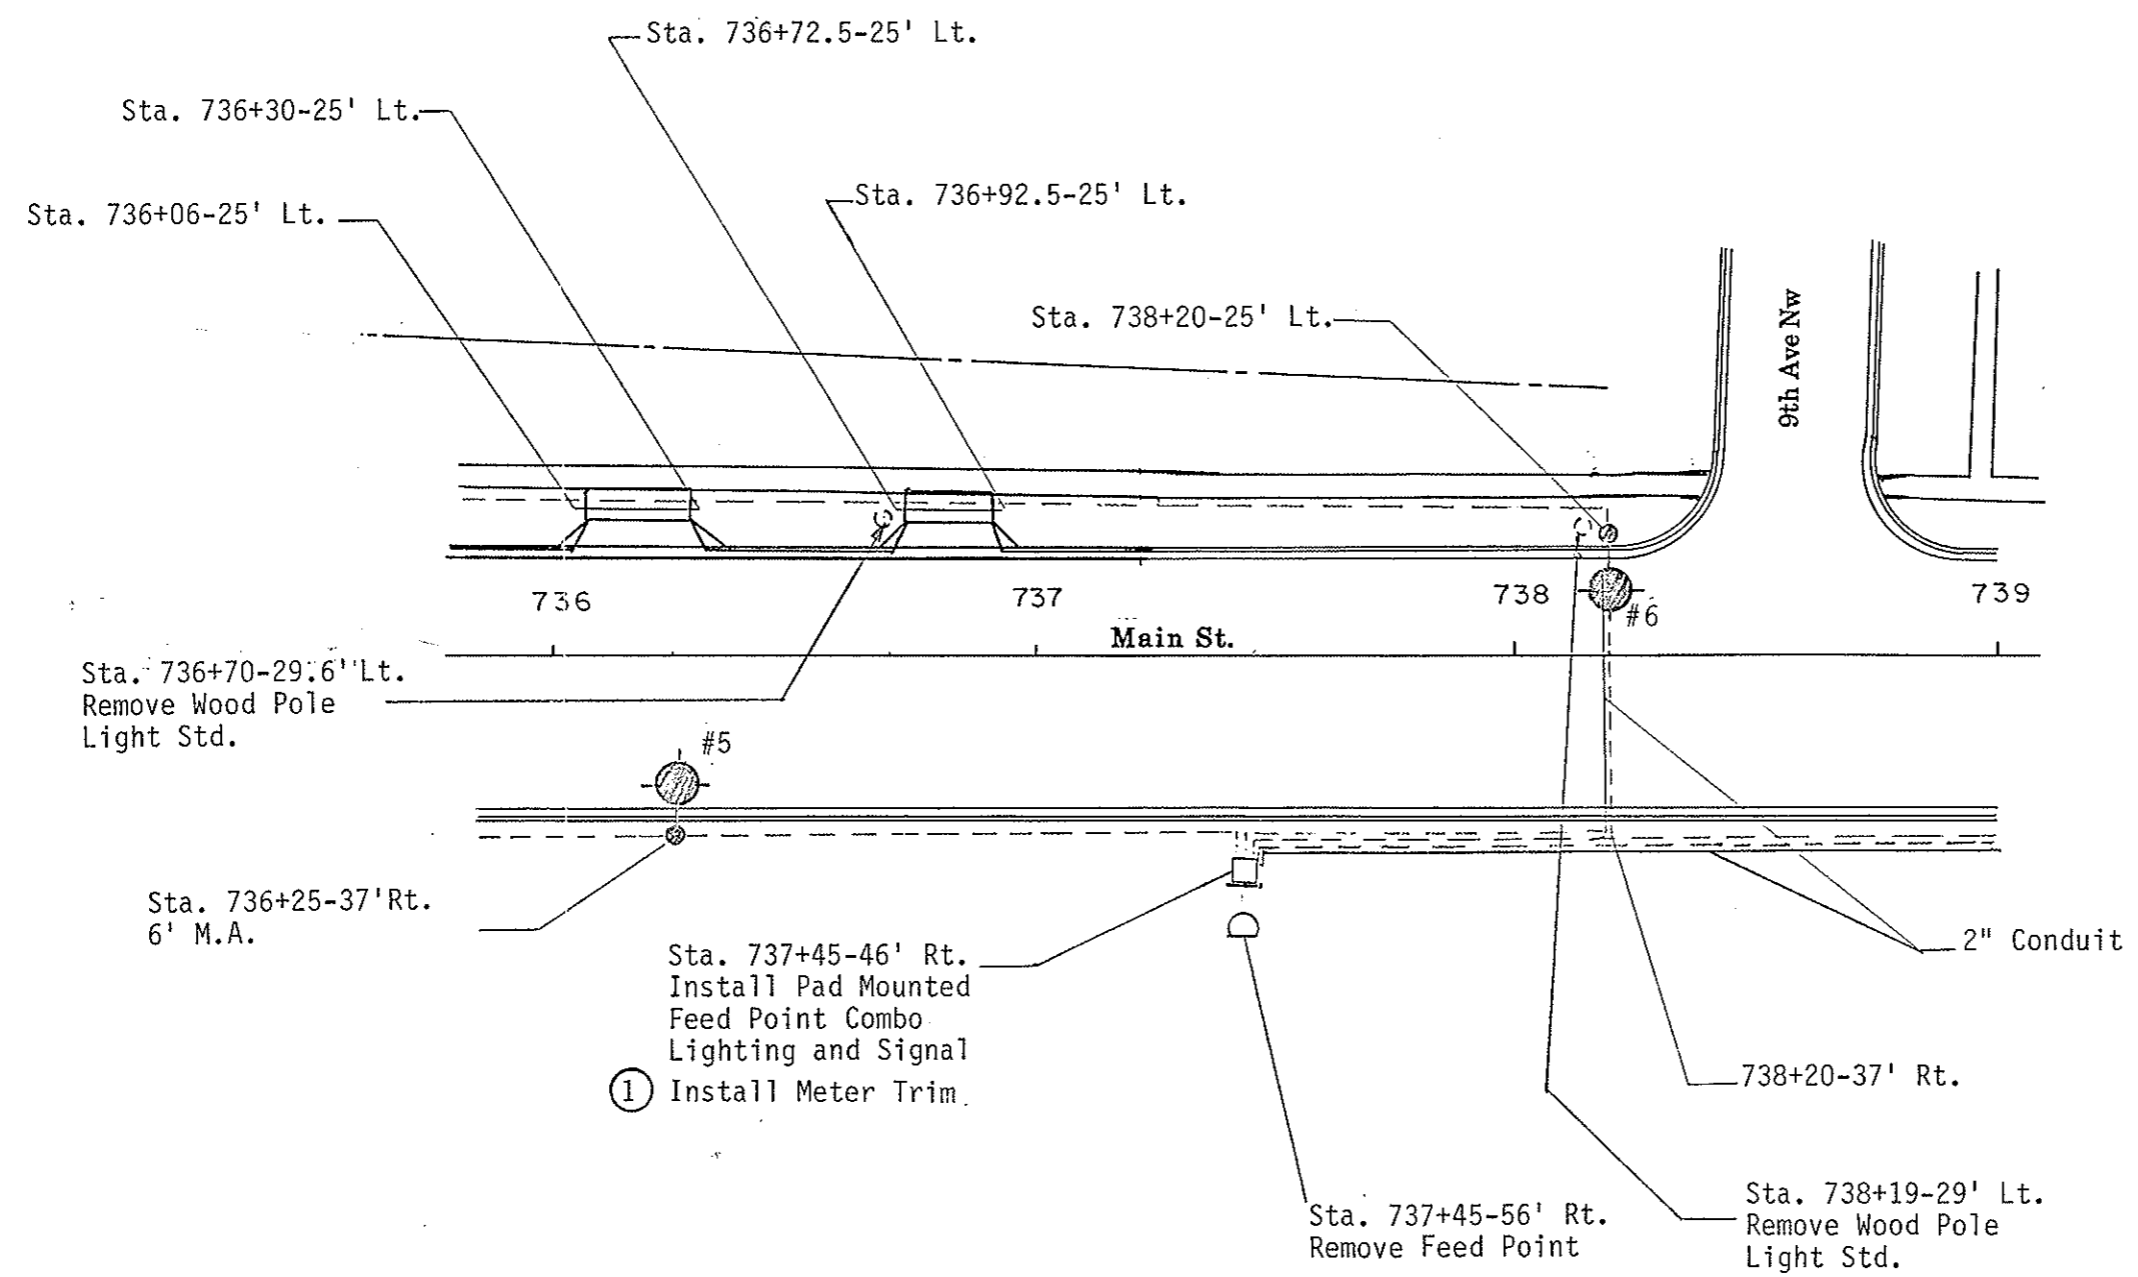

**TRAFFIC CONTROL SYSTEM**  
 Lighting Layout  
 Sta. 736+00 to 739+00  
 Main St.  
 10th Ave. sw ( ND Hwy 6 )  
 Mandan N.D.