

AS-BUILTS

WATER & SEWER IMPROVEMENT


DISTRICT NO. 40

MANDAN, NORTH DAKOTA

CITY PROJECT NO. 96-9


INDEX OF DRAWINGS

SHT #	TITLE	TECO #
1	TITLE SHEET	
2	AREA "A" - HIGHWAY 1806 SANITARY LIFT STATION	1122
3	AREA "A" - HIGHWAY 1806 SANITARY SEWER	1126
4	AREA "A" - GRADING PLAN (NICOLA'S 4TH ADD.)	1126
5	AREA "A" - 10TH ST SE & ALLEY W & S (NICOLA'S 4TH ADD.)	1126
6	AREA "A" - 10TH ST SE & ALLEY STORM SEWER (NICOLA'S 4TH ADD.)	2091
7	AREA "B" - 12TH AVE SE & 14TH ST SE	1125
8	AREA "C" - TERRA VALLEE SANITARY LIFT STATION	1123
9	AREA "C" - TERRA VALLEE SANITARY SEWER	1123
10	DETAILS	
11	ELECTRICAL DETAILS	
CHANGE ORDER NO. 5		
2	AREA "D" - PLAN & PROFILE - 14TH AVENUE S.E.	1145
3	AREA "D" - PLAN & PROFILE - 14TH AVENUE S.E., CONT.	1145
4	SAME AS SHEET NO. 10	1145

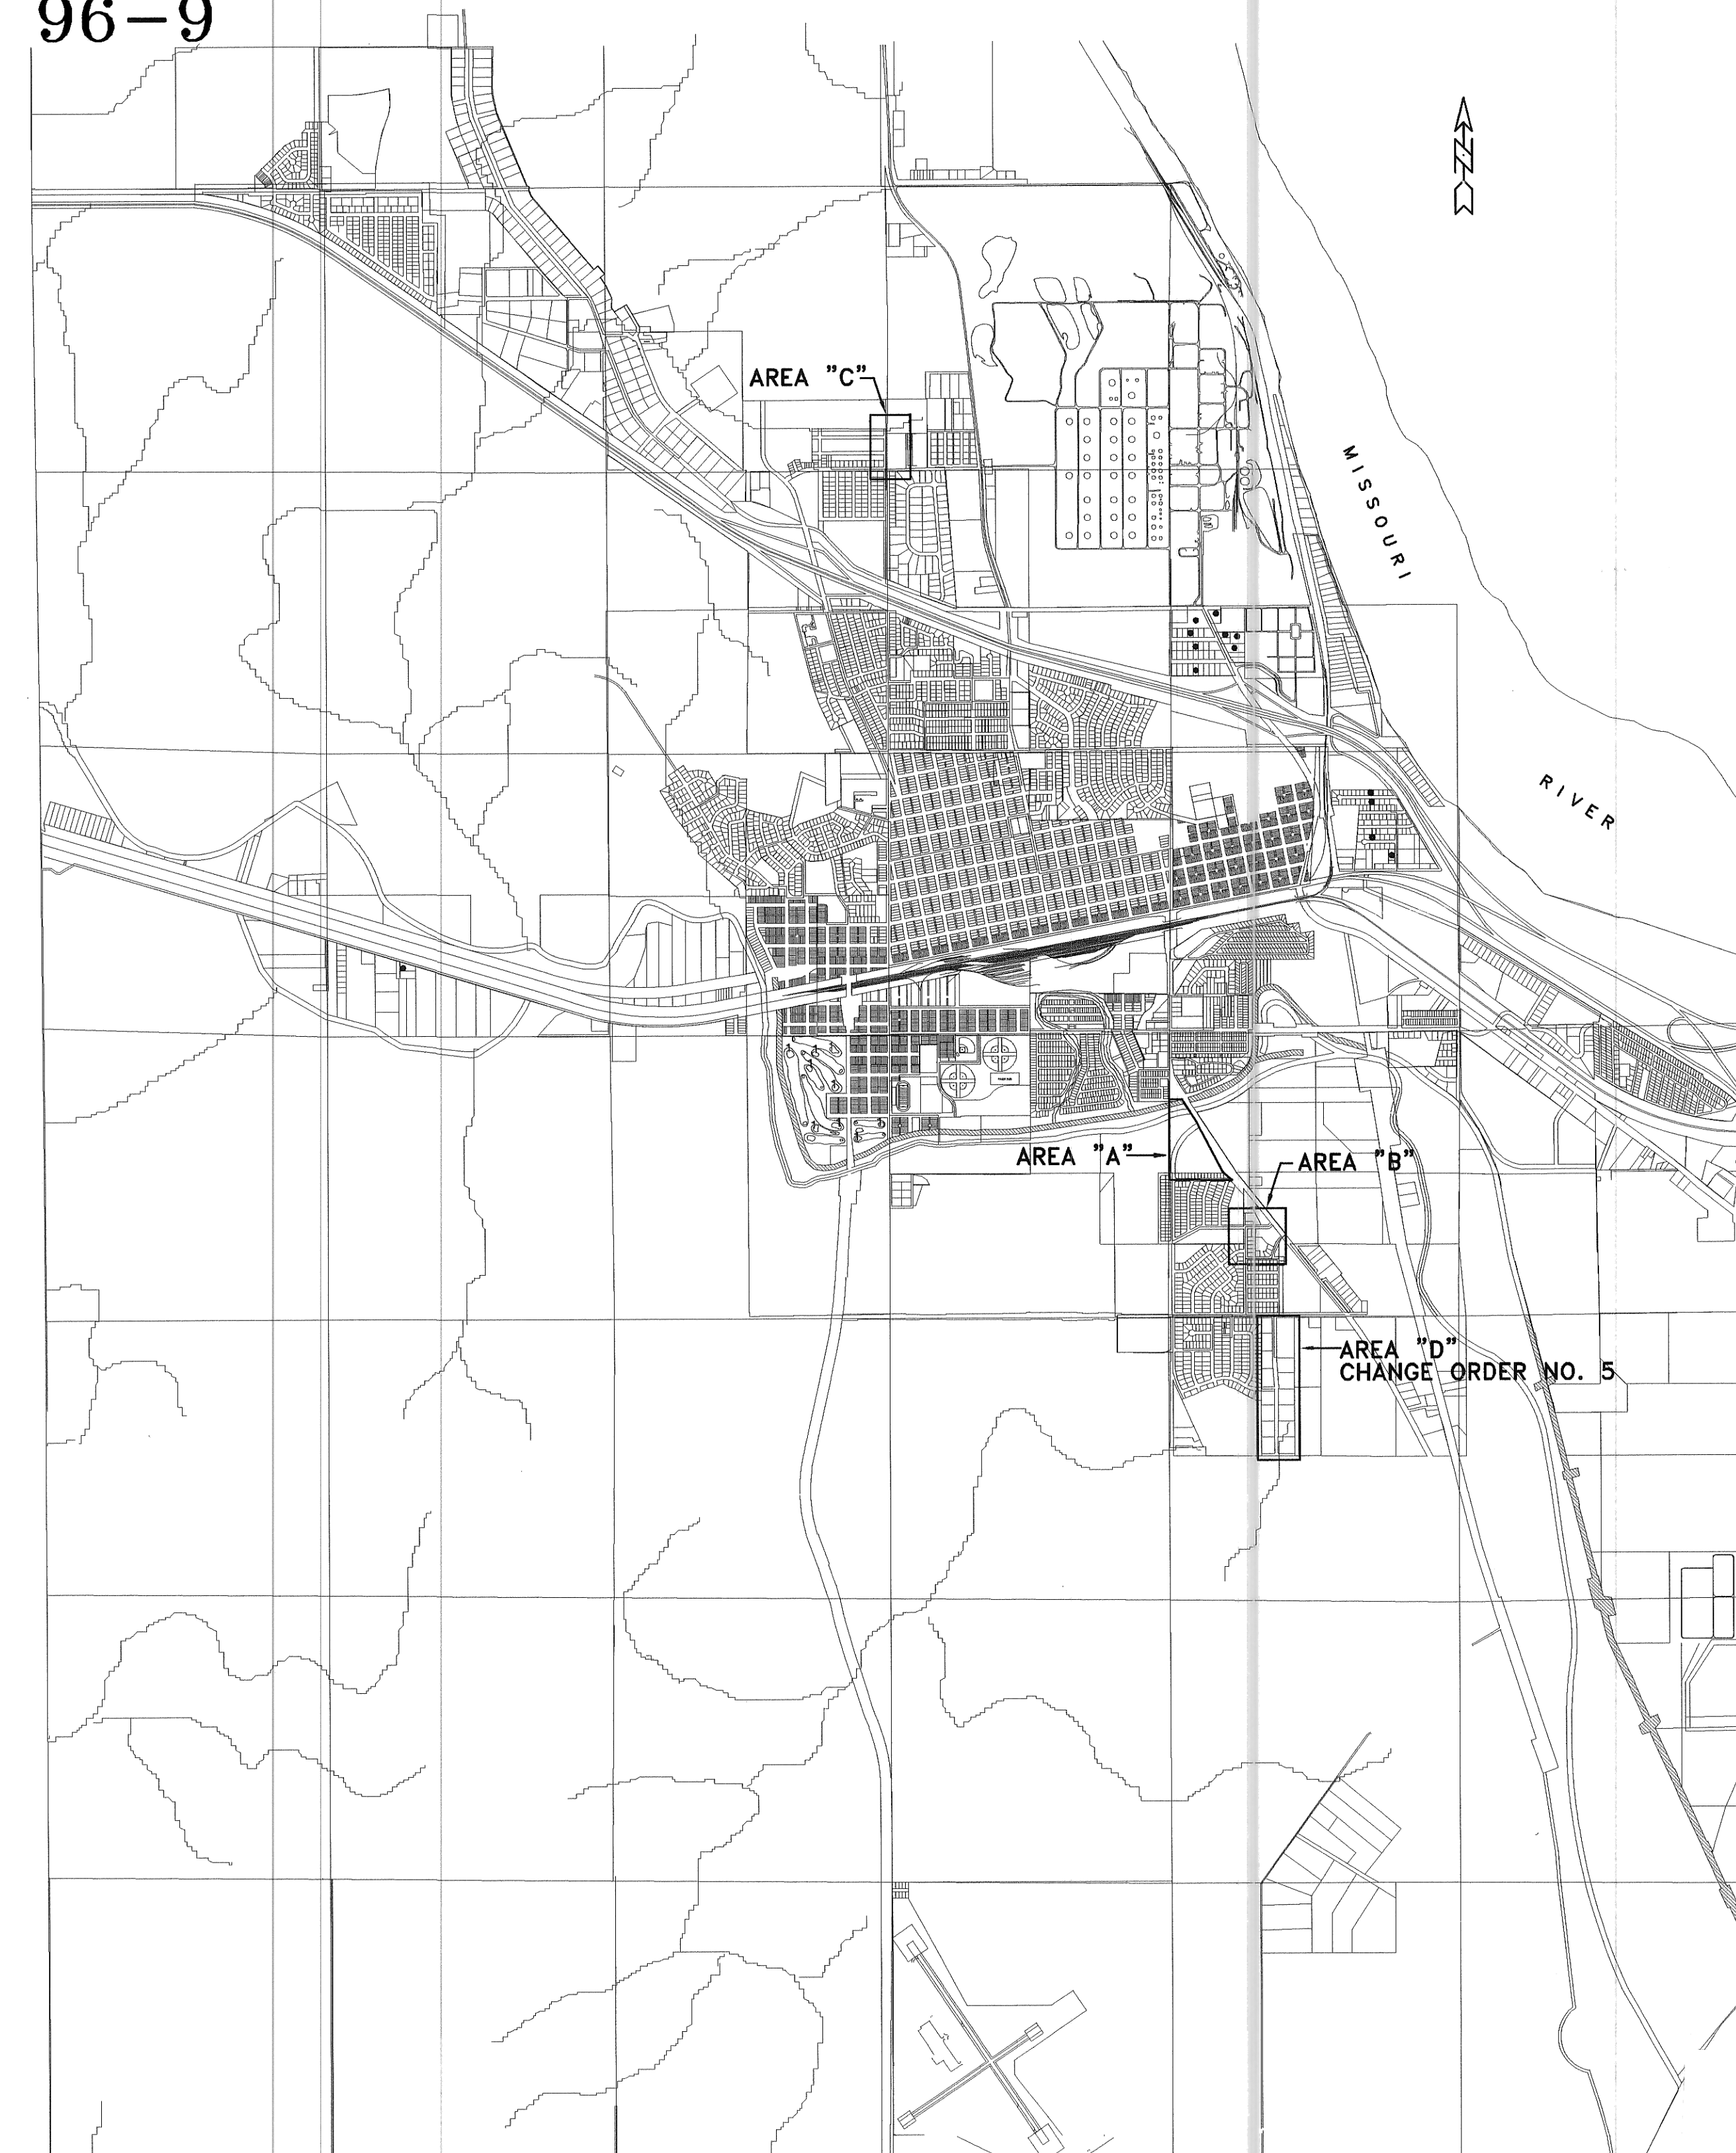

THOMAS LITTLE, R.P.E. CITY ENGINEER, MANDAN, NORTH DAKOTA

TOMAN ENGINEERING, RONALD MANCHESTER R.P.E. 3252
DATE: FEBRUARY, 1997

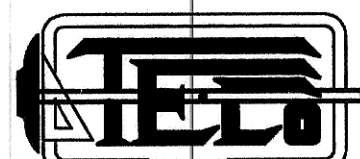

TOMAN ENGINEERING COMPANY
CONSULTING CIVIL & ENVIRONMENTAL ENGINEERS
906 2ND STREET NW • MANDAN, NORTH DAKOTA 58554
(701) 663-6463



DRAWING TITLE: 02/10/99 PLOT TIME: 09:57:29 TOMAN #3