


# AS BUILT STORM WATER PUMP REPLACEMENT STANDBY GENERATOR & GENERATOR BUILDING REPLACEMENT IN THE CITY OF MANDAN, NORTH DAKOTA

SEPTEMBER, 2001

## INDEX OF DRAWINGS

SHEET NO.	TITLE
1	TITLE SHEET
2	SITE LAYOUT
3	EXISTING STRUCTURES
4	INSTALLED STRUCTURES
5	E-1 SITE PLAN-ELECTRICAL
6	E-2 FLOOR PLANS ELECTRICAL
7	E-3 SCHEDULES & DETAILS
8	E-4 PANEL FEEDER & RISER DIAGRAMS
7277-GENERATOR BUILDING	
9	WALL OPENINGS & LAYOUTS
10	WALL & ROOF DETAILS
11	FOOTING & FLOOR DETAILS
12	FOUNDATION WALL DETAILS
<del>13</del>	<del>PROPOSED ROAD PLAN &amp; PROFILE</del>
<del>14</del>	<del>PROPOSED ROAD CROSS SECTIONS #1</del>
<del>15</del>	<del>PROPOSED ROAD CROSS SECTIONS #2</del>
7277-A STORM PUMP REPLACEMENT	
16	16" L-SERIES VERTICAL DUAL INPUT PUMP DETAILS
17	PUMP CUTOUTS & SLUICE GATE DETAILS

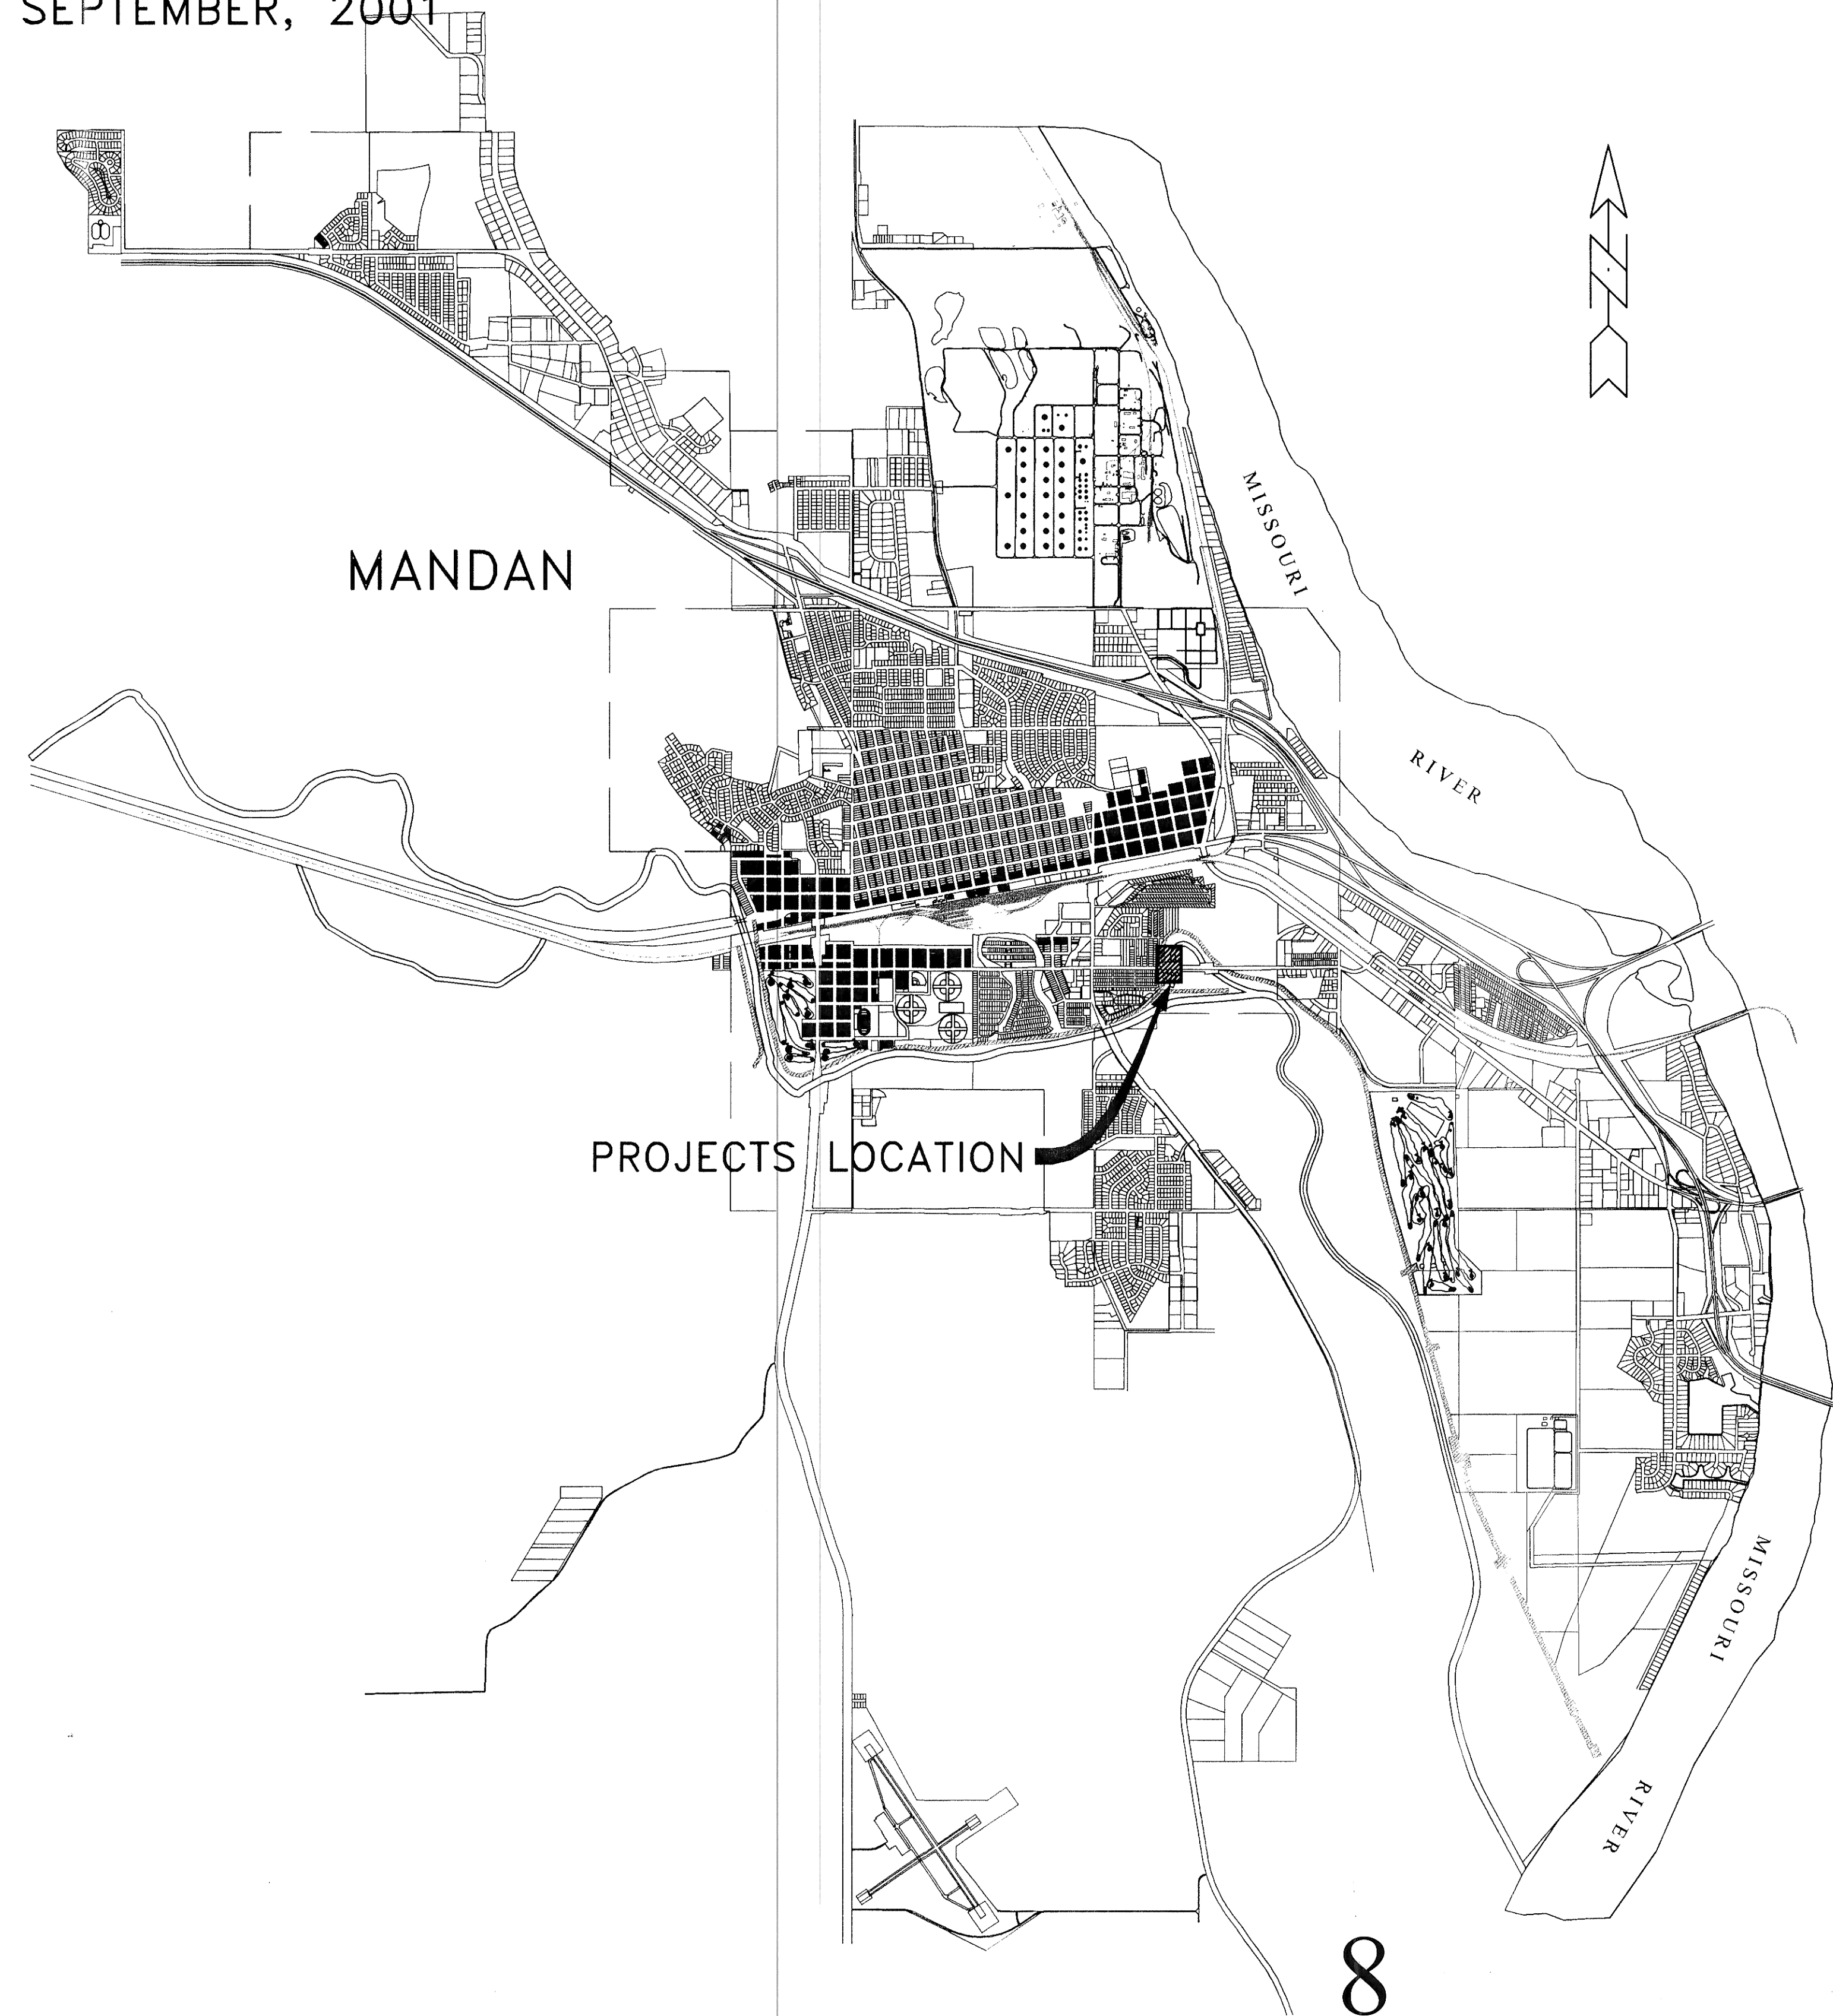

PREPARED BY:  
TOMAN ENGINEERING  
*Ronald W. Manchester*  
RONALD MANCHESTER R.P.E. 3252

DATE: 11/21/03



2000-26

8

SHEET 1 OF 17 SHEETS