


POWER VENT AND CURB DETAIL  
N.T.S.



1 DETAIL @ END WALL  
A-2

2 DETAIL @ END WALL  
A-2


3 DETAIL @ BEARING WALL  
A-2

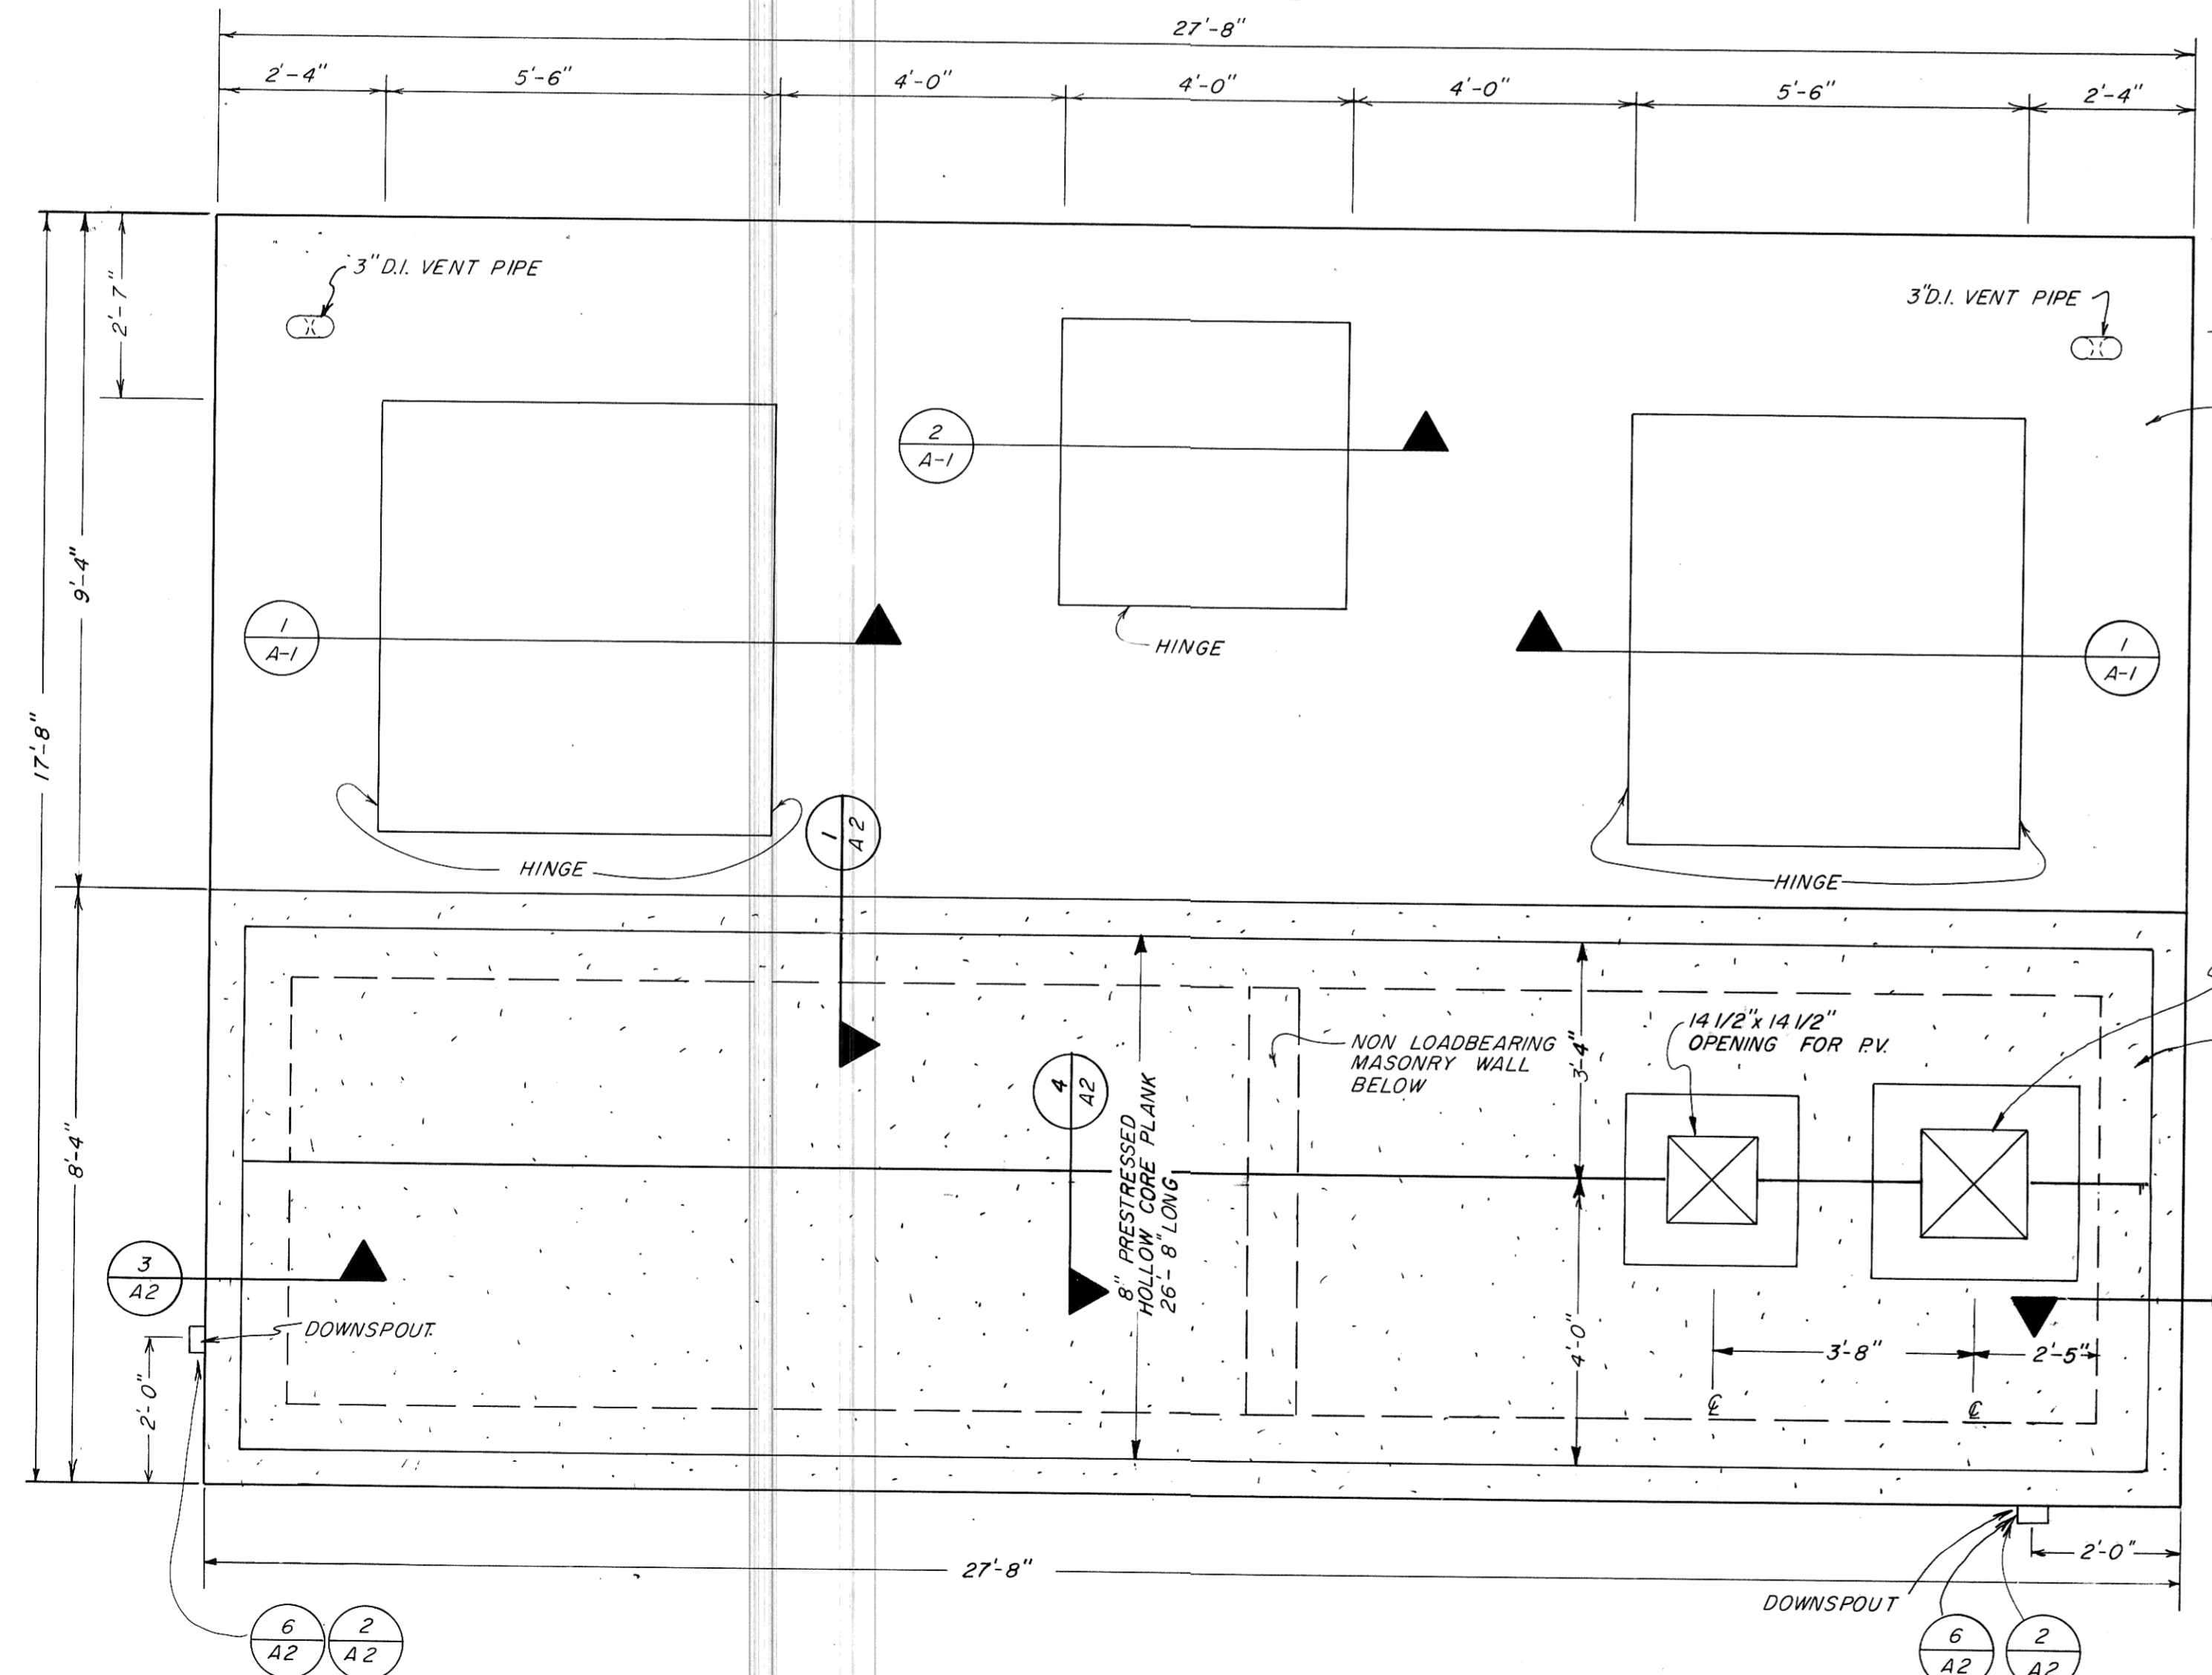

5 ROOF PLAN  
SEE SHEET A-3 FOR ELEVATION VIEWS

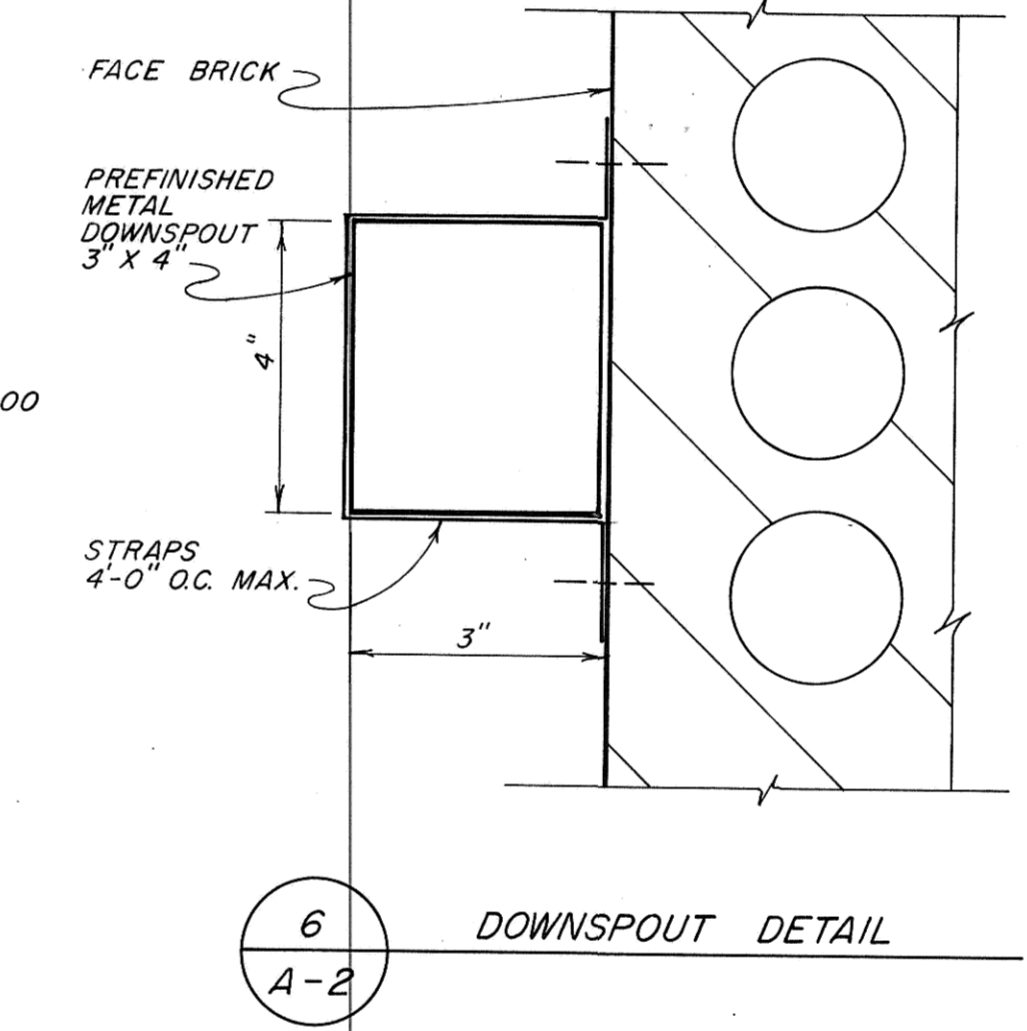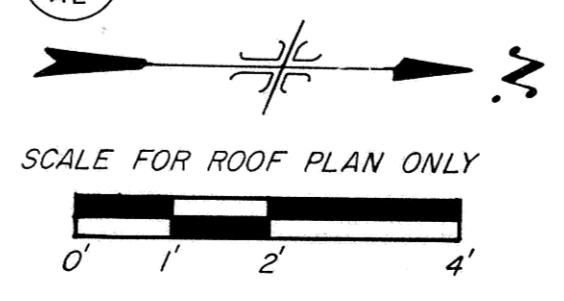

6 DOWNSPOUT DETAIL  
A-2

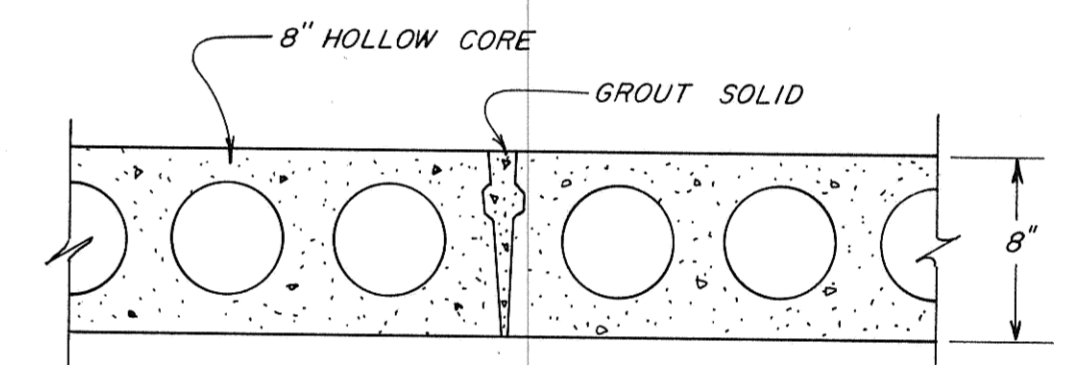

4 JOINT DETAIL  
A-2

PHASE III

REV.	DATE	DESCRIPTION	BY

MANDAN INTERCEPTOR 1984  
MANDAN, NORTH DAKOTA

MASTER PUMPING STATION  
ROOF PLAN

ULTEIG ENGINEERS, INC. CONSULTING ENGINEERS • ARCHITECT  
FARGO • BISMARCK • MINNEAPOLIS

DRAWN BY: M.P.K. SCALE: AS SHOWN PROJECT NO. 4241.00  
CHECKED BY: [Signature] DATE: MAY 1984  
APPROVED BY: [Signature] SHEET A-2 of



Record Drawing