




**BUILDING SECTION**

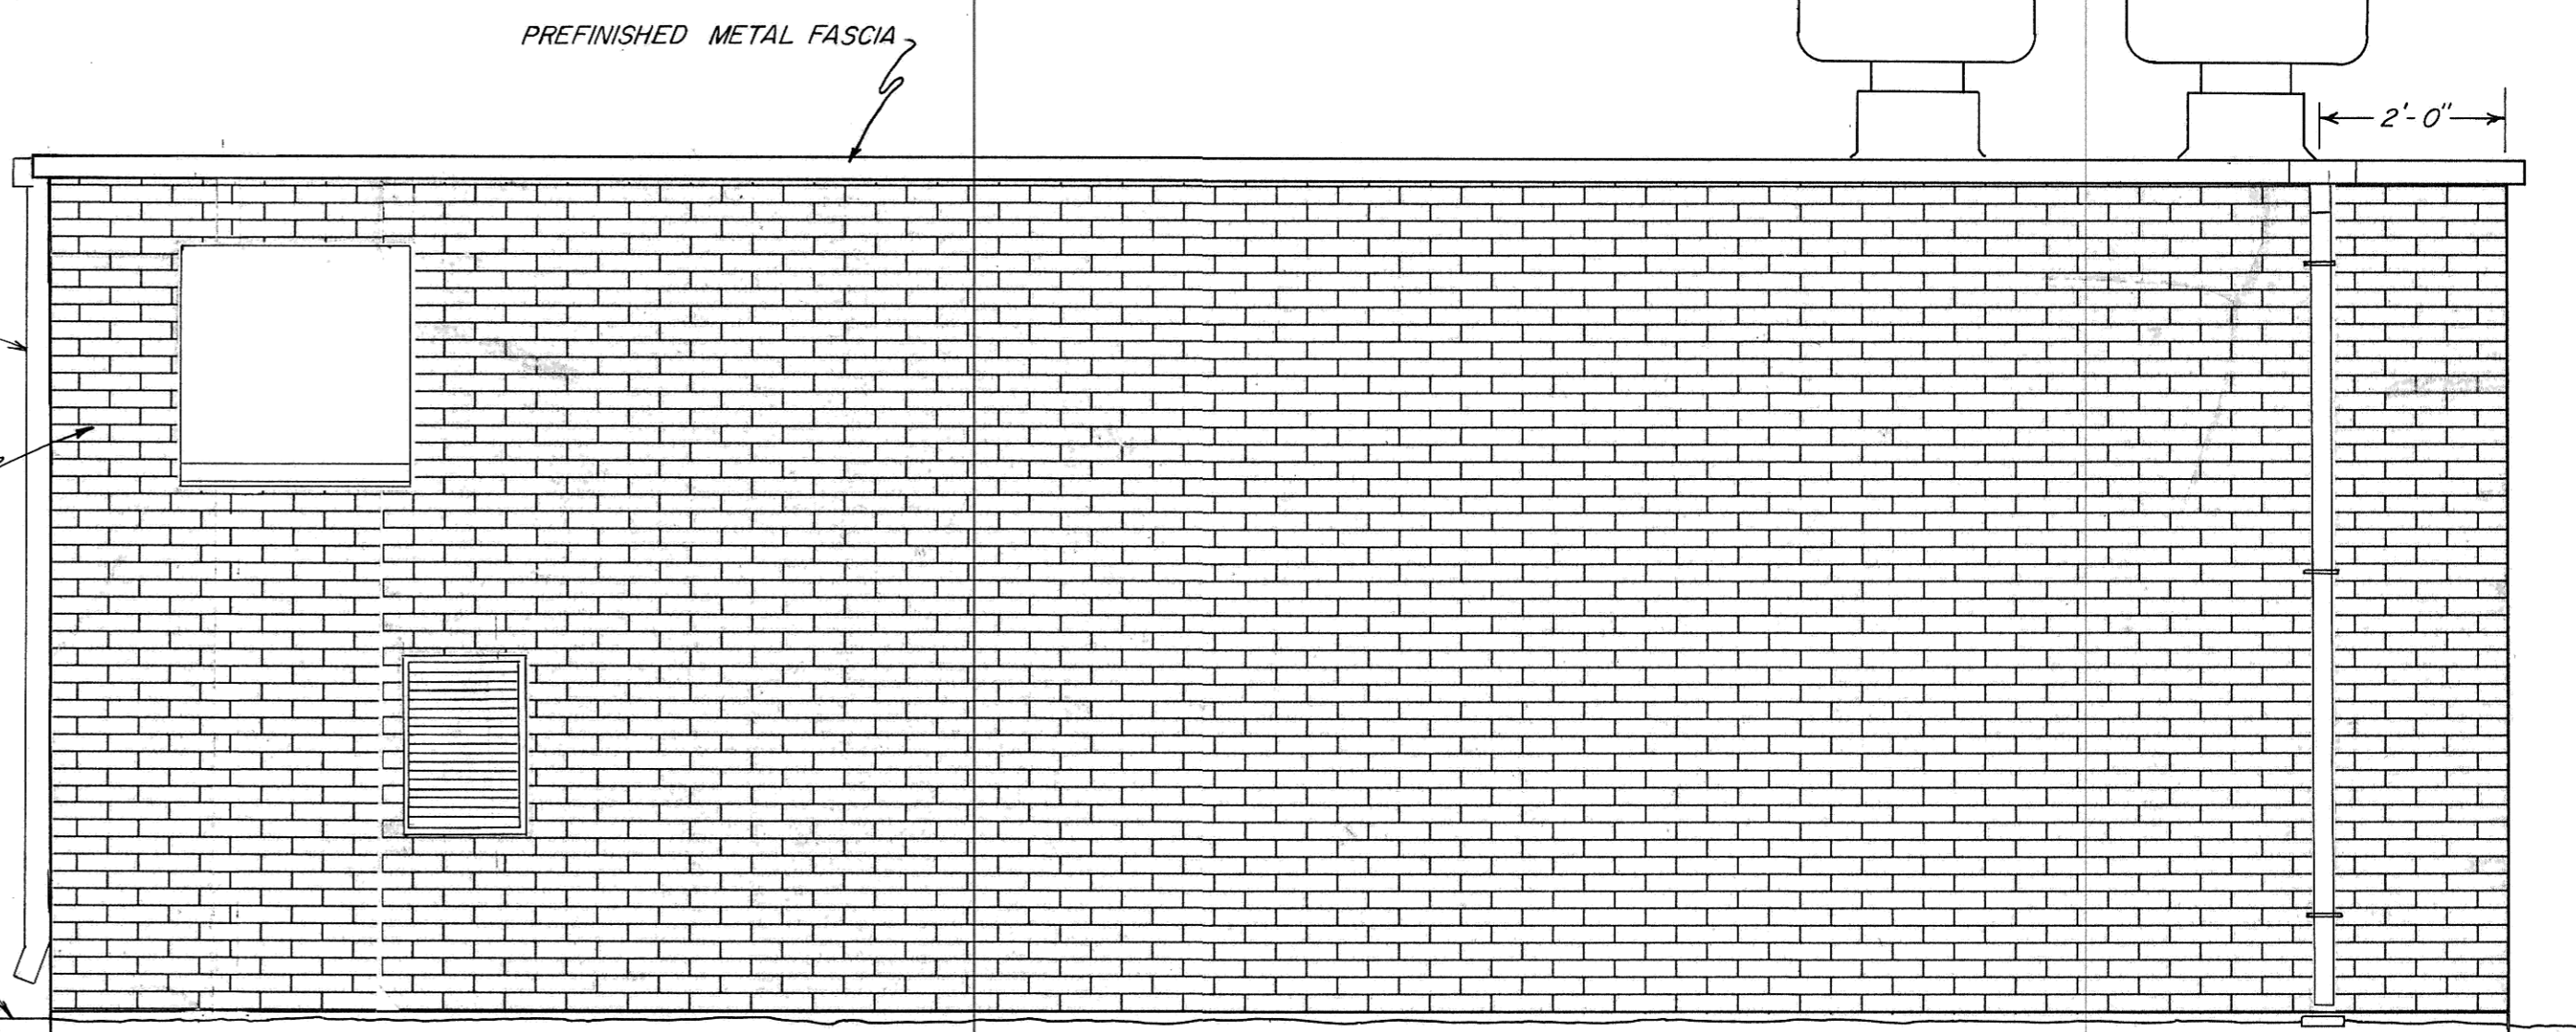


**EAST ELEVATION**

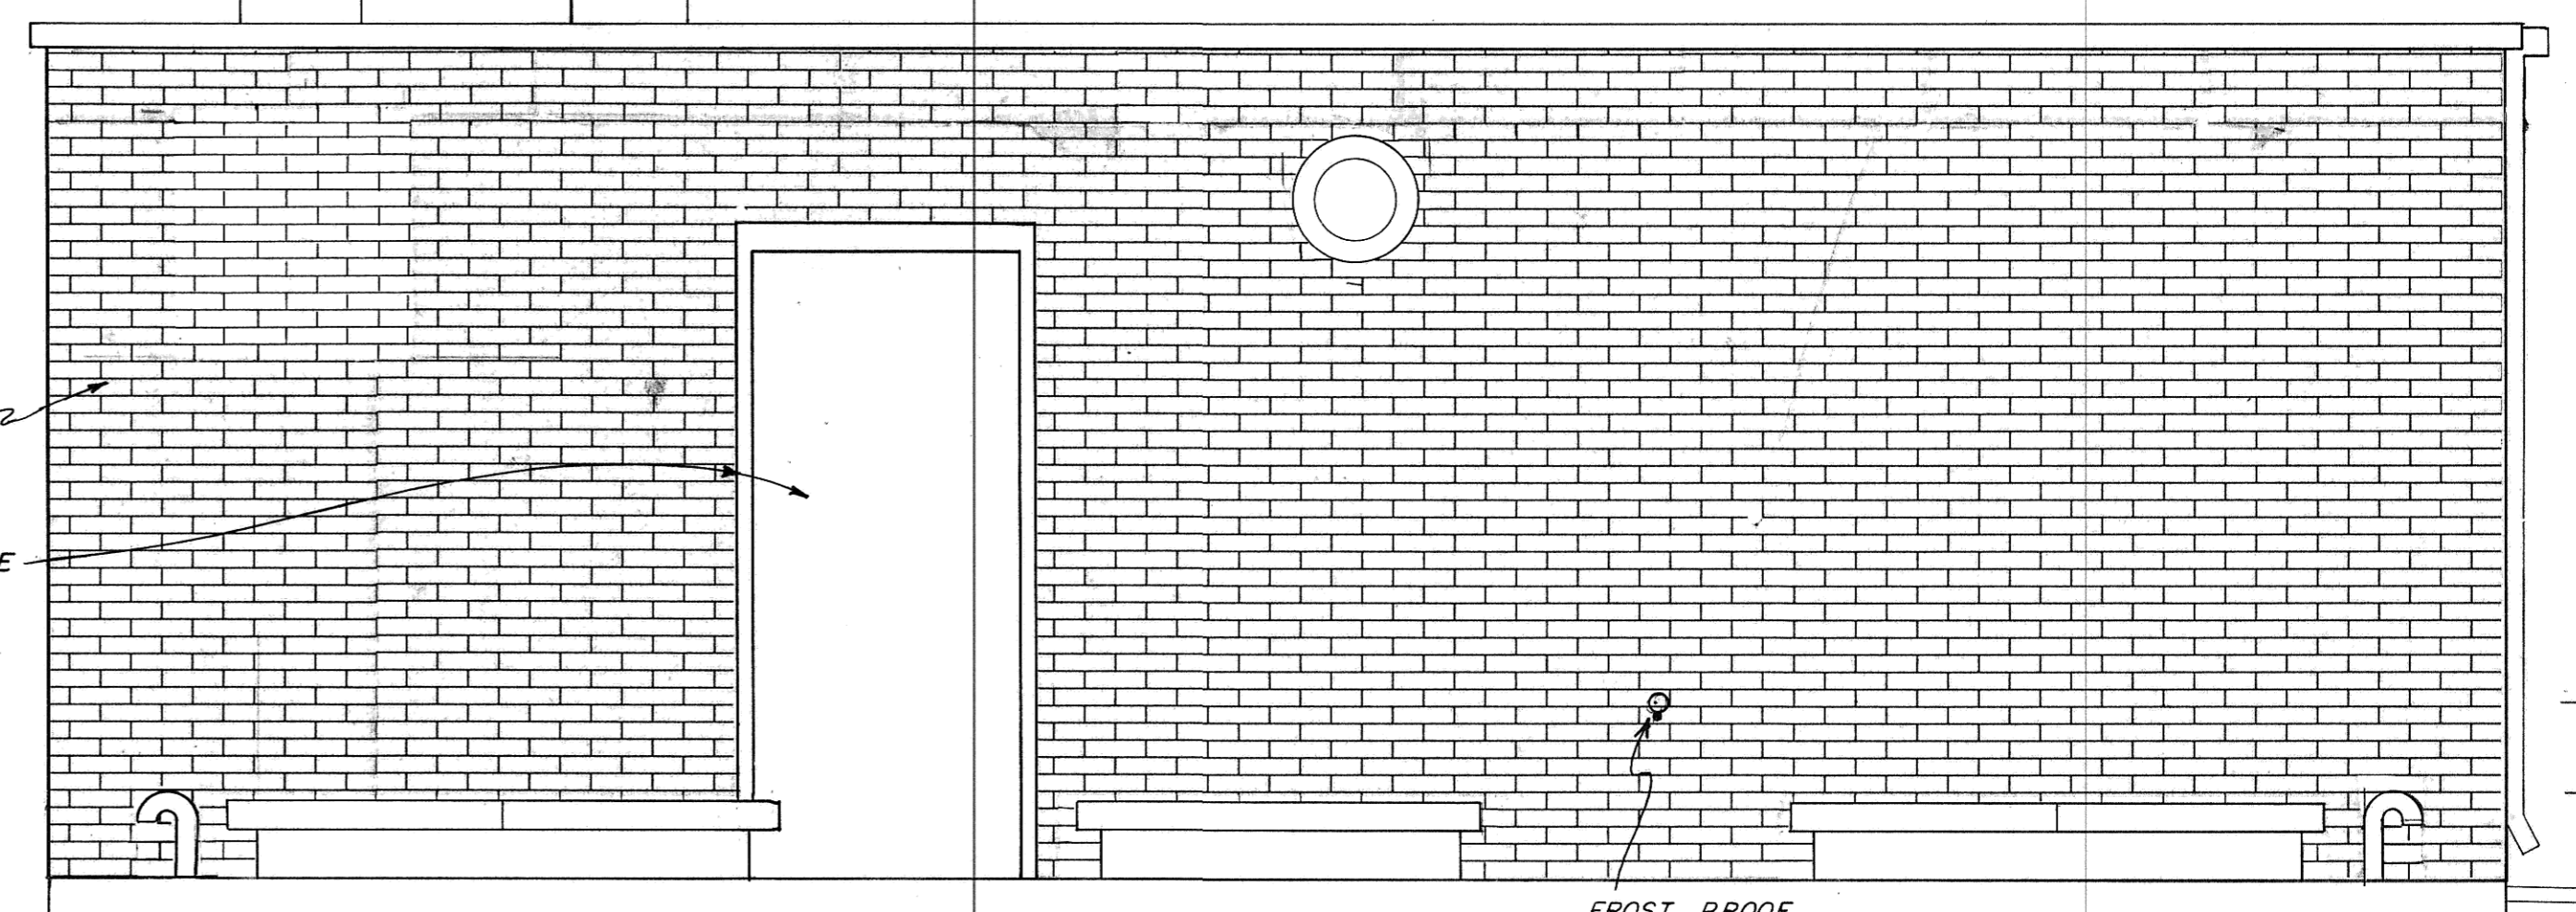


**WEST ELEVATION**

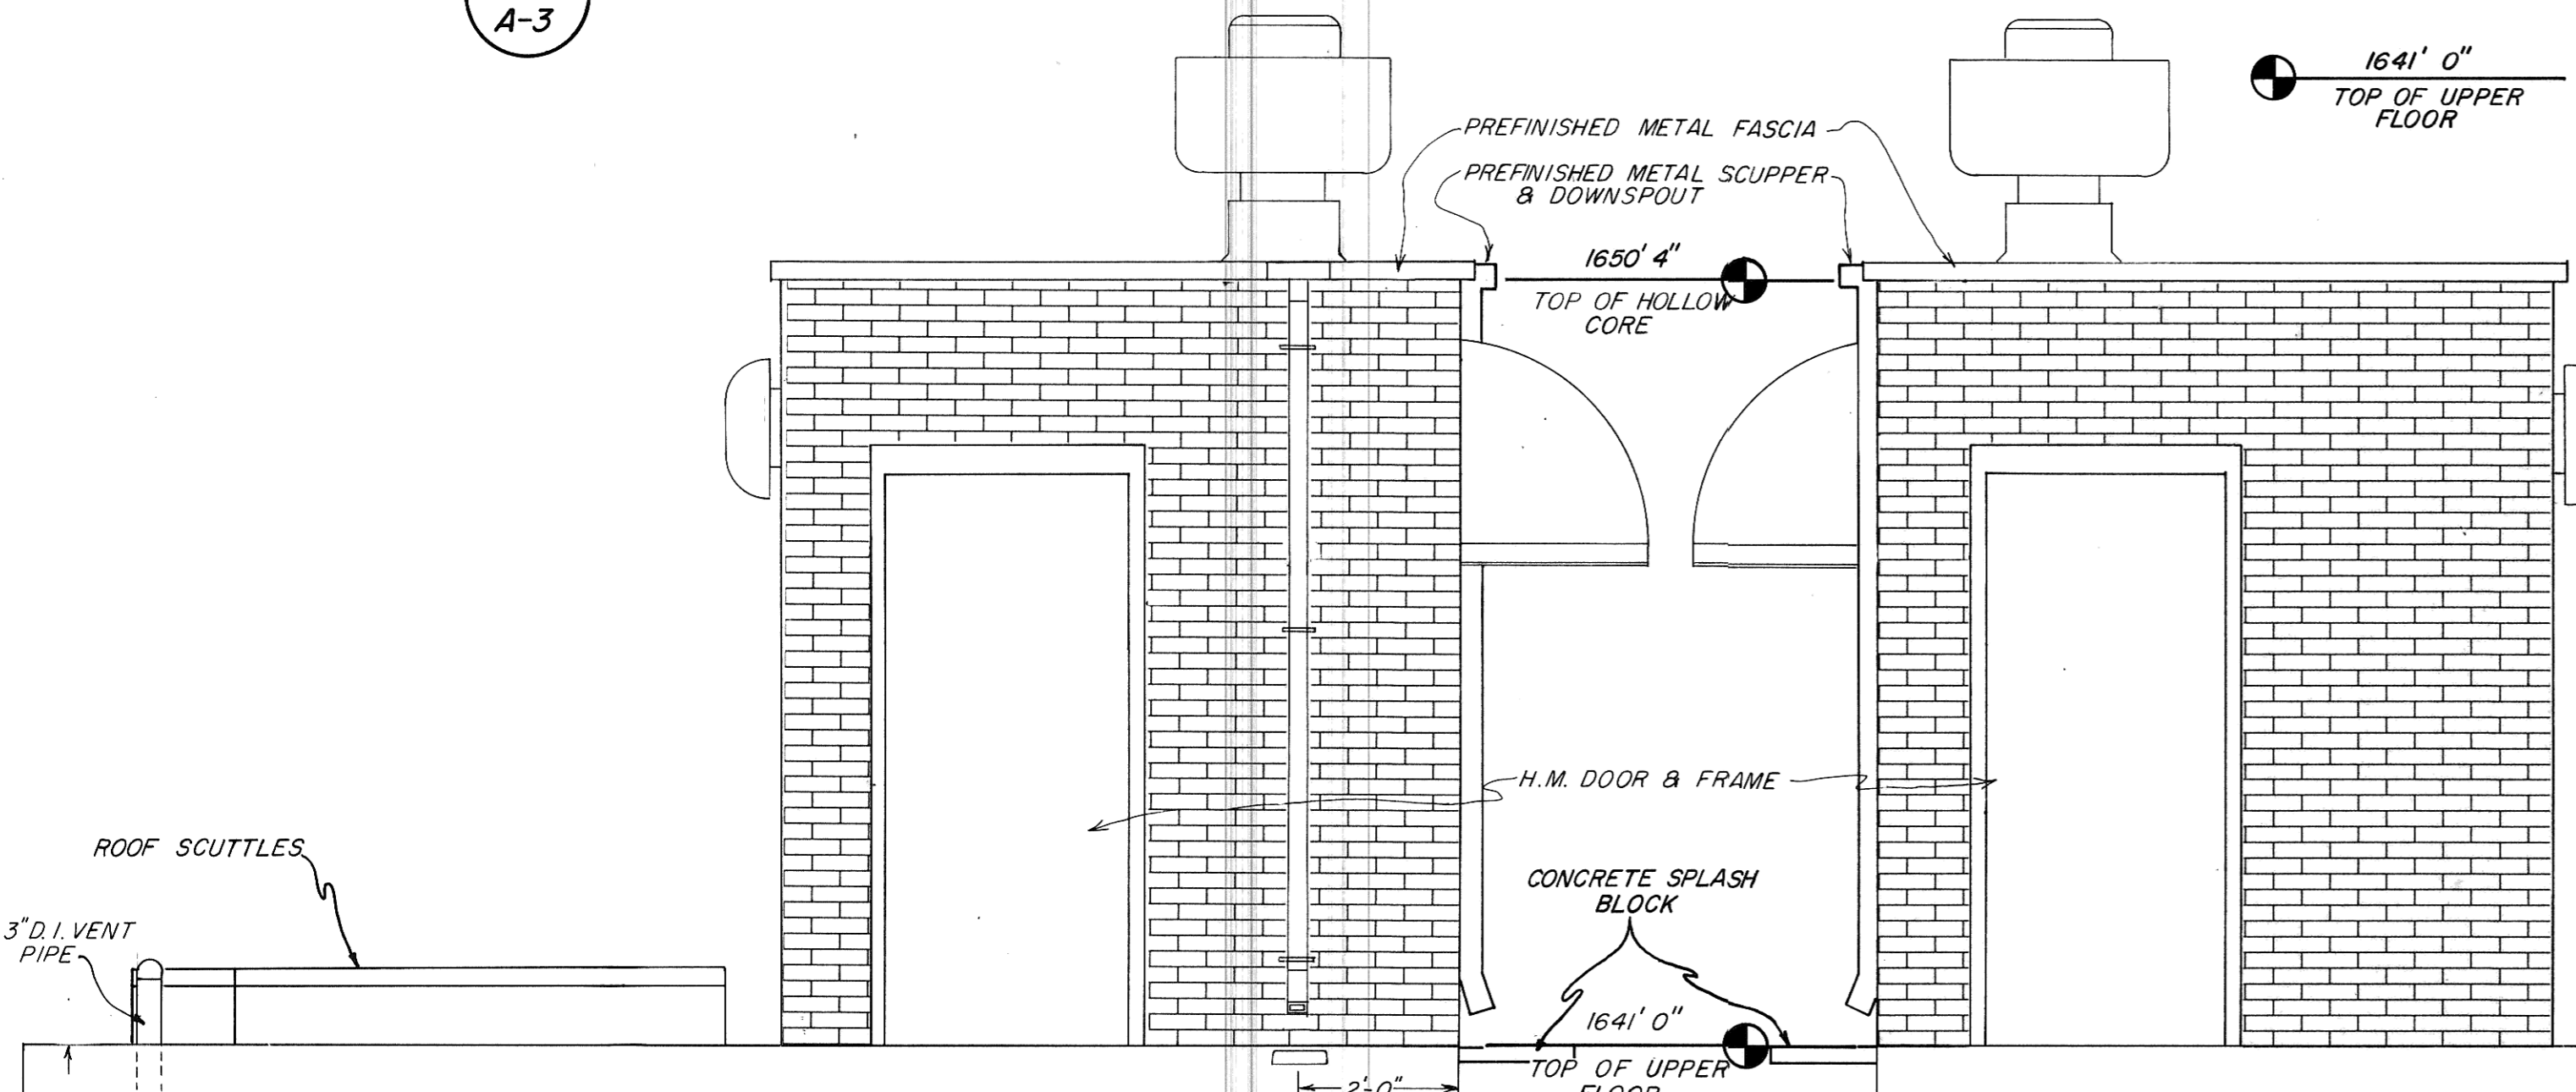


**SOUTH ELEVATION**

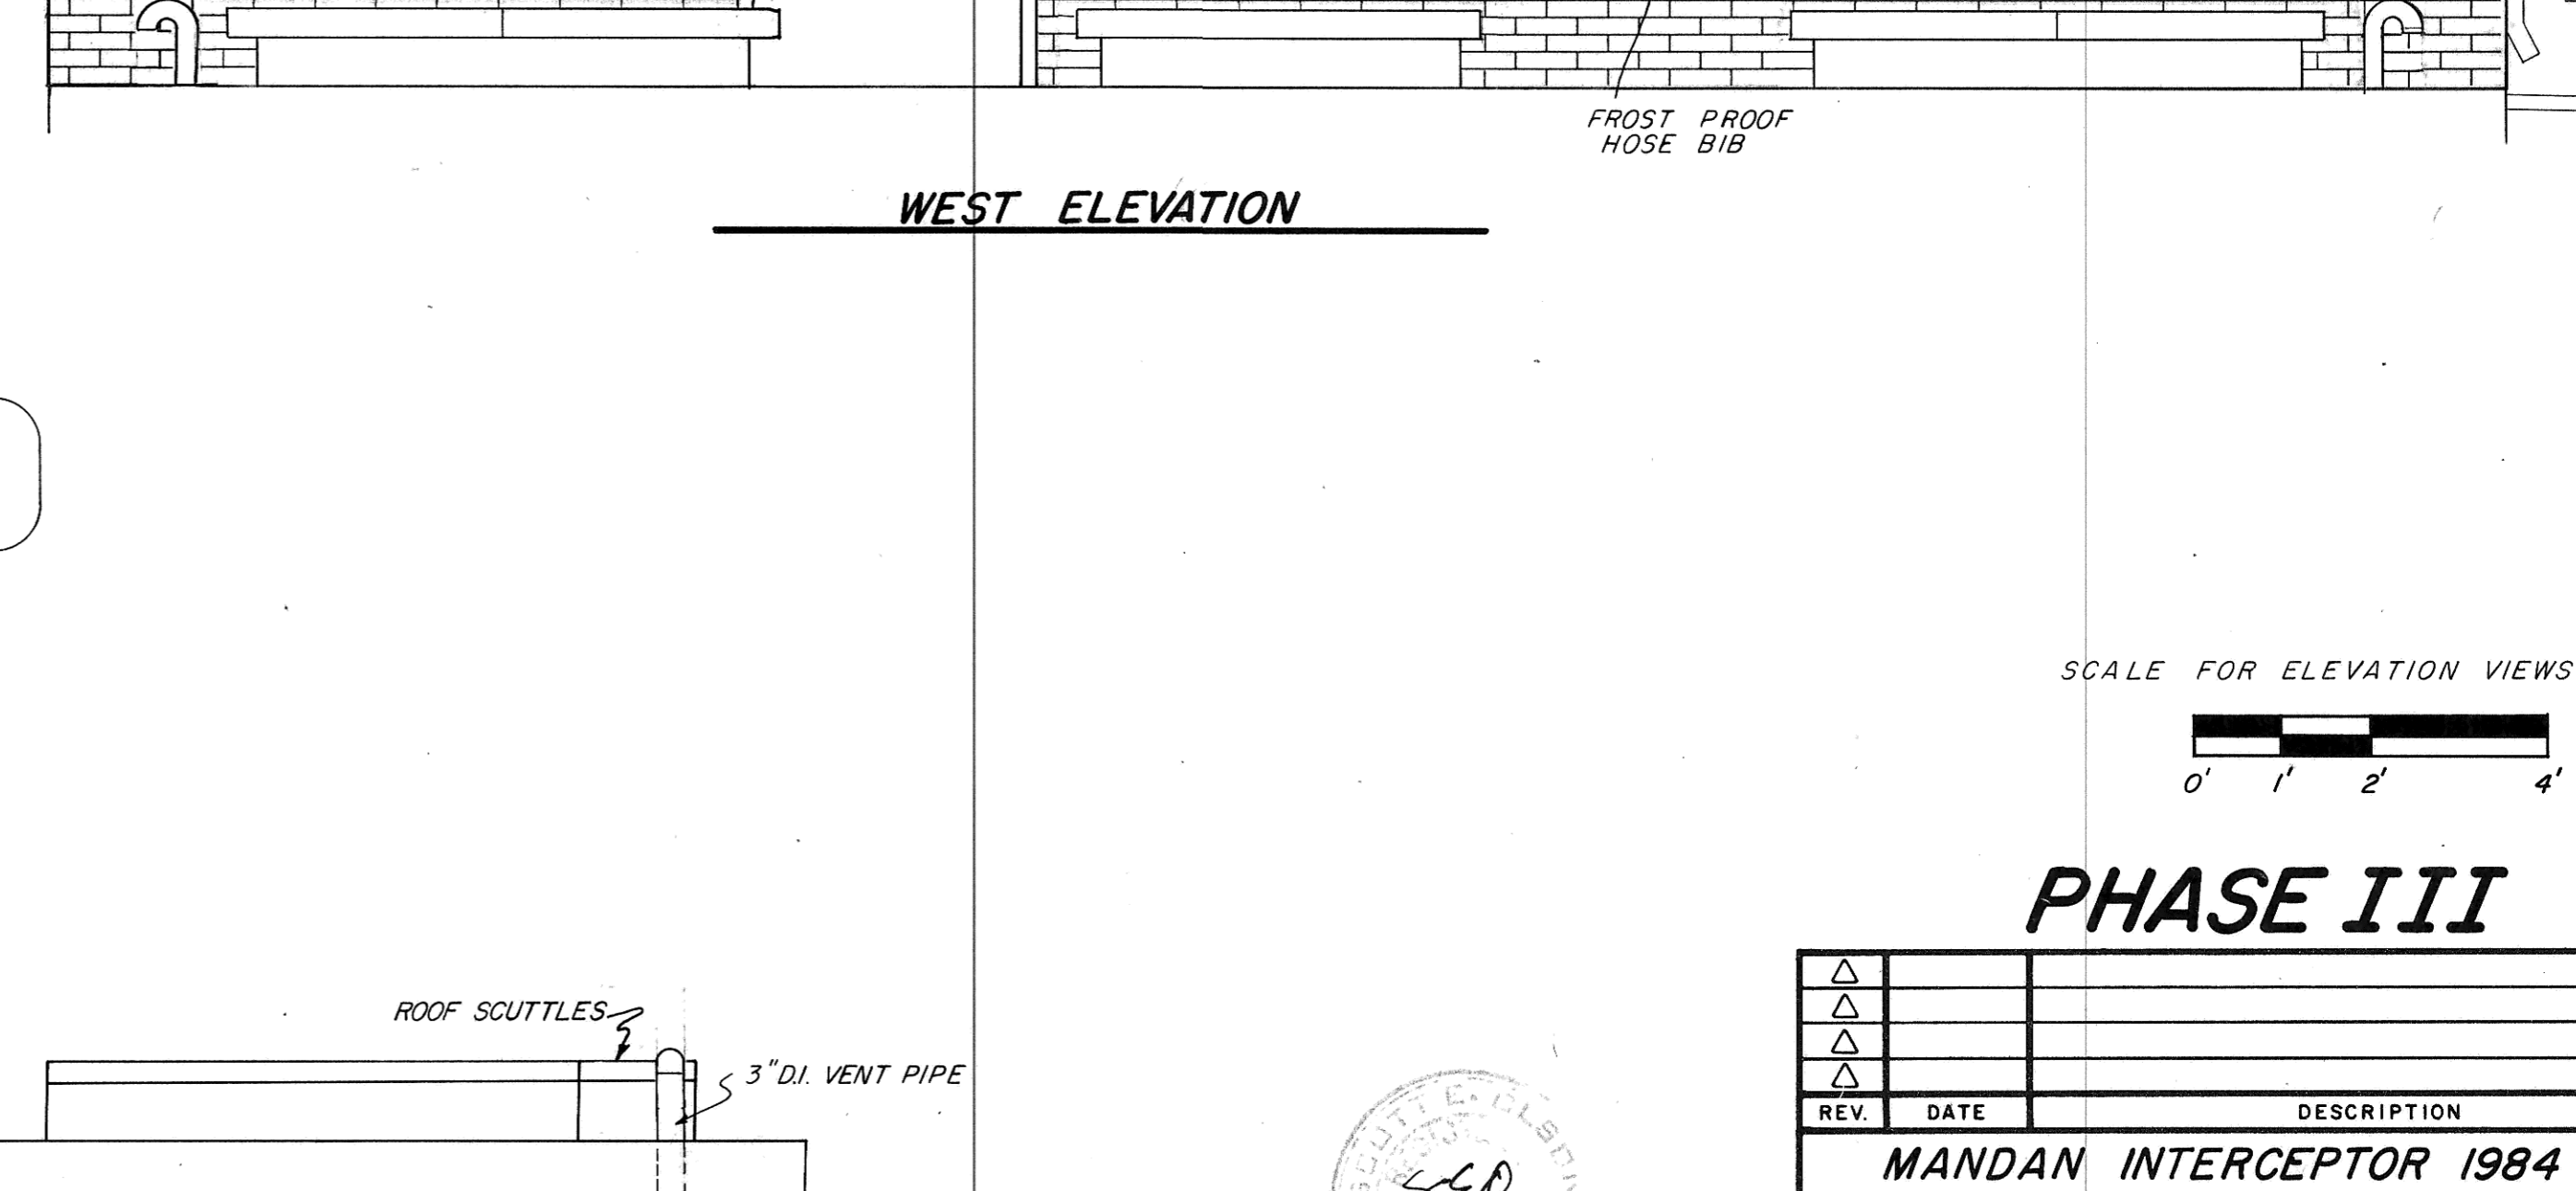

**NORTH ELEVATION**

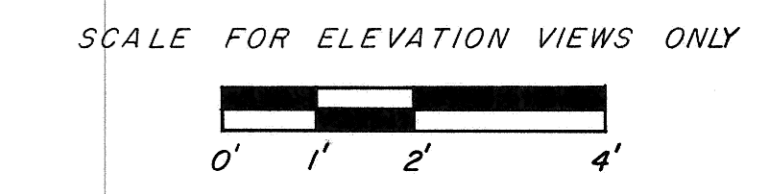

**PHASE III**

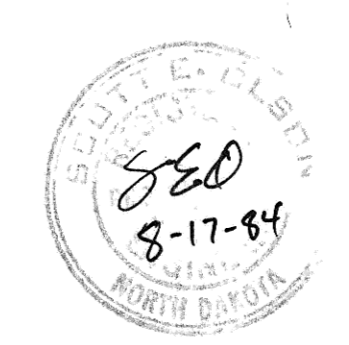

Record Drawing

REV.	DATE	DESCRIPTION	BY

<b>MANDAN INTERCEPTOR 1984</b>		
<b>MANDAN, NORTH DAKOTA</b>		
MASTER PUMPING STATION SECTION & ELEVATION VIEWS		
ULTEIG ENGINEERS, INC. CONSULTING ENGINEERS & ARCHITECT FARGO • BISMARCK • MINNEAPOLIS		
DRAWN BY: T.R.	SCALE: AS SHOWN	PROJECT NO. 4241
CHECKED BY: [Signature]	DATE: MAY 1984	SHEET A-3 of
APPROVED BY: [Signature]		