


SCALE: 1" = 4'

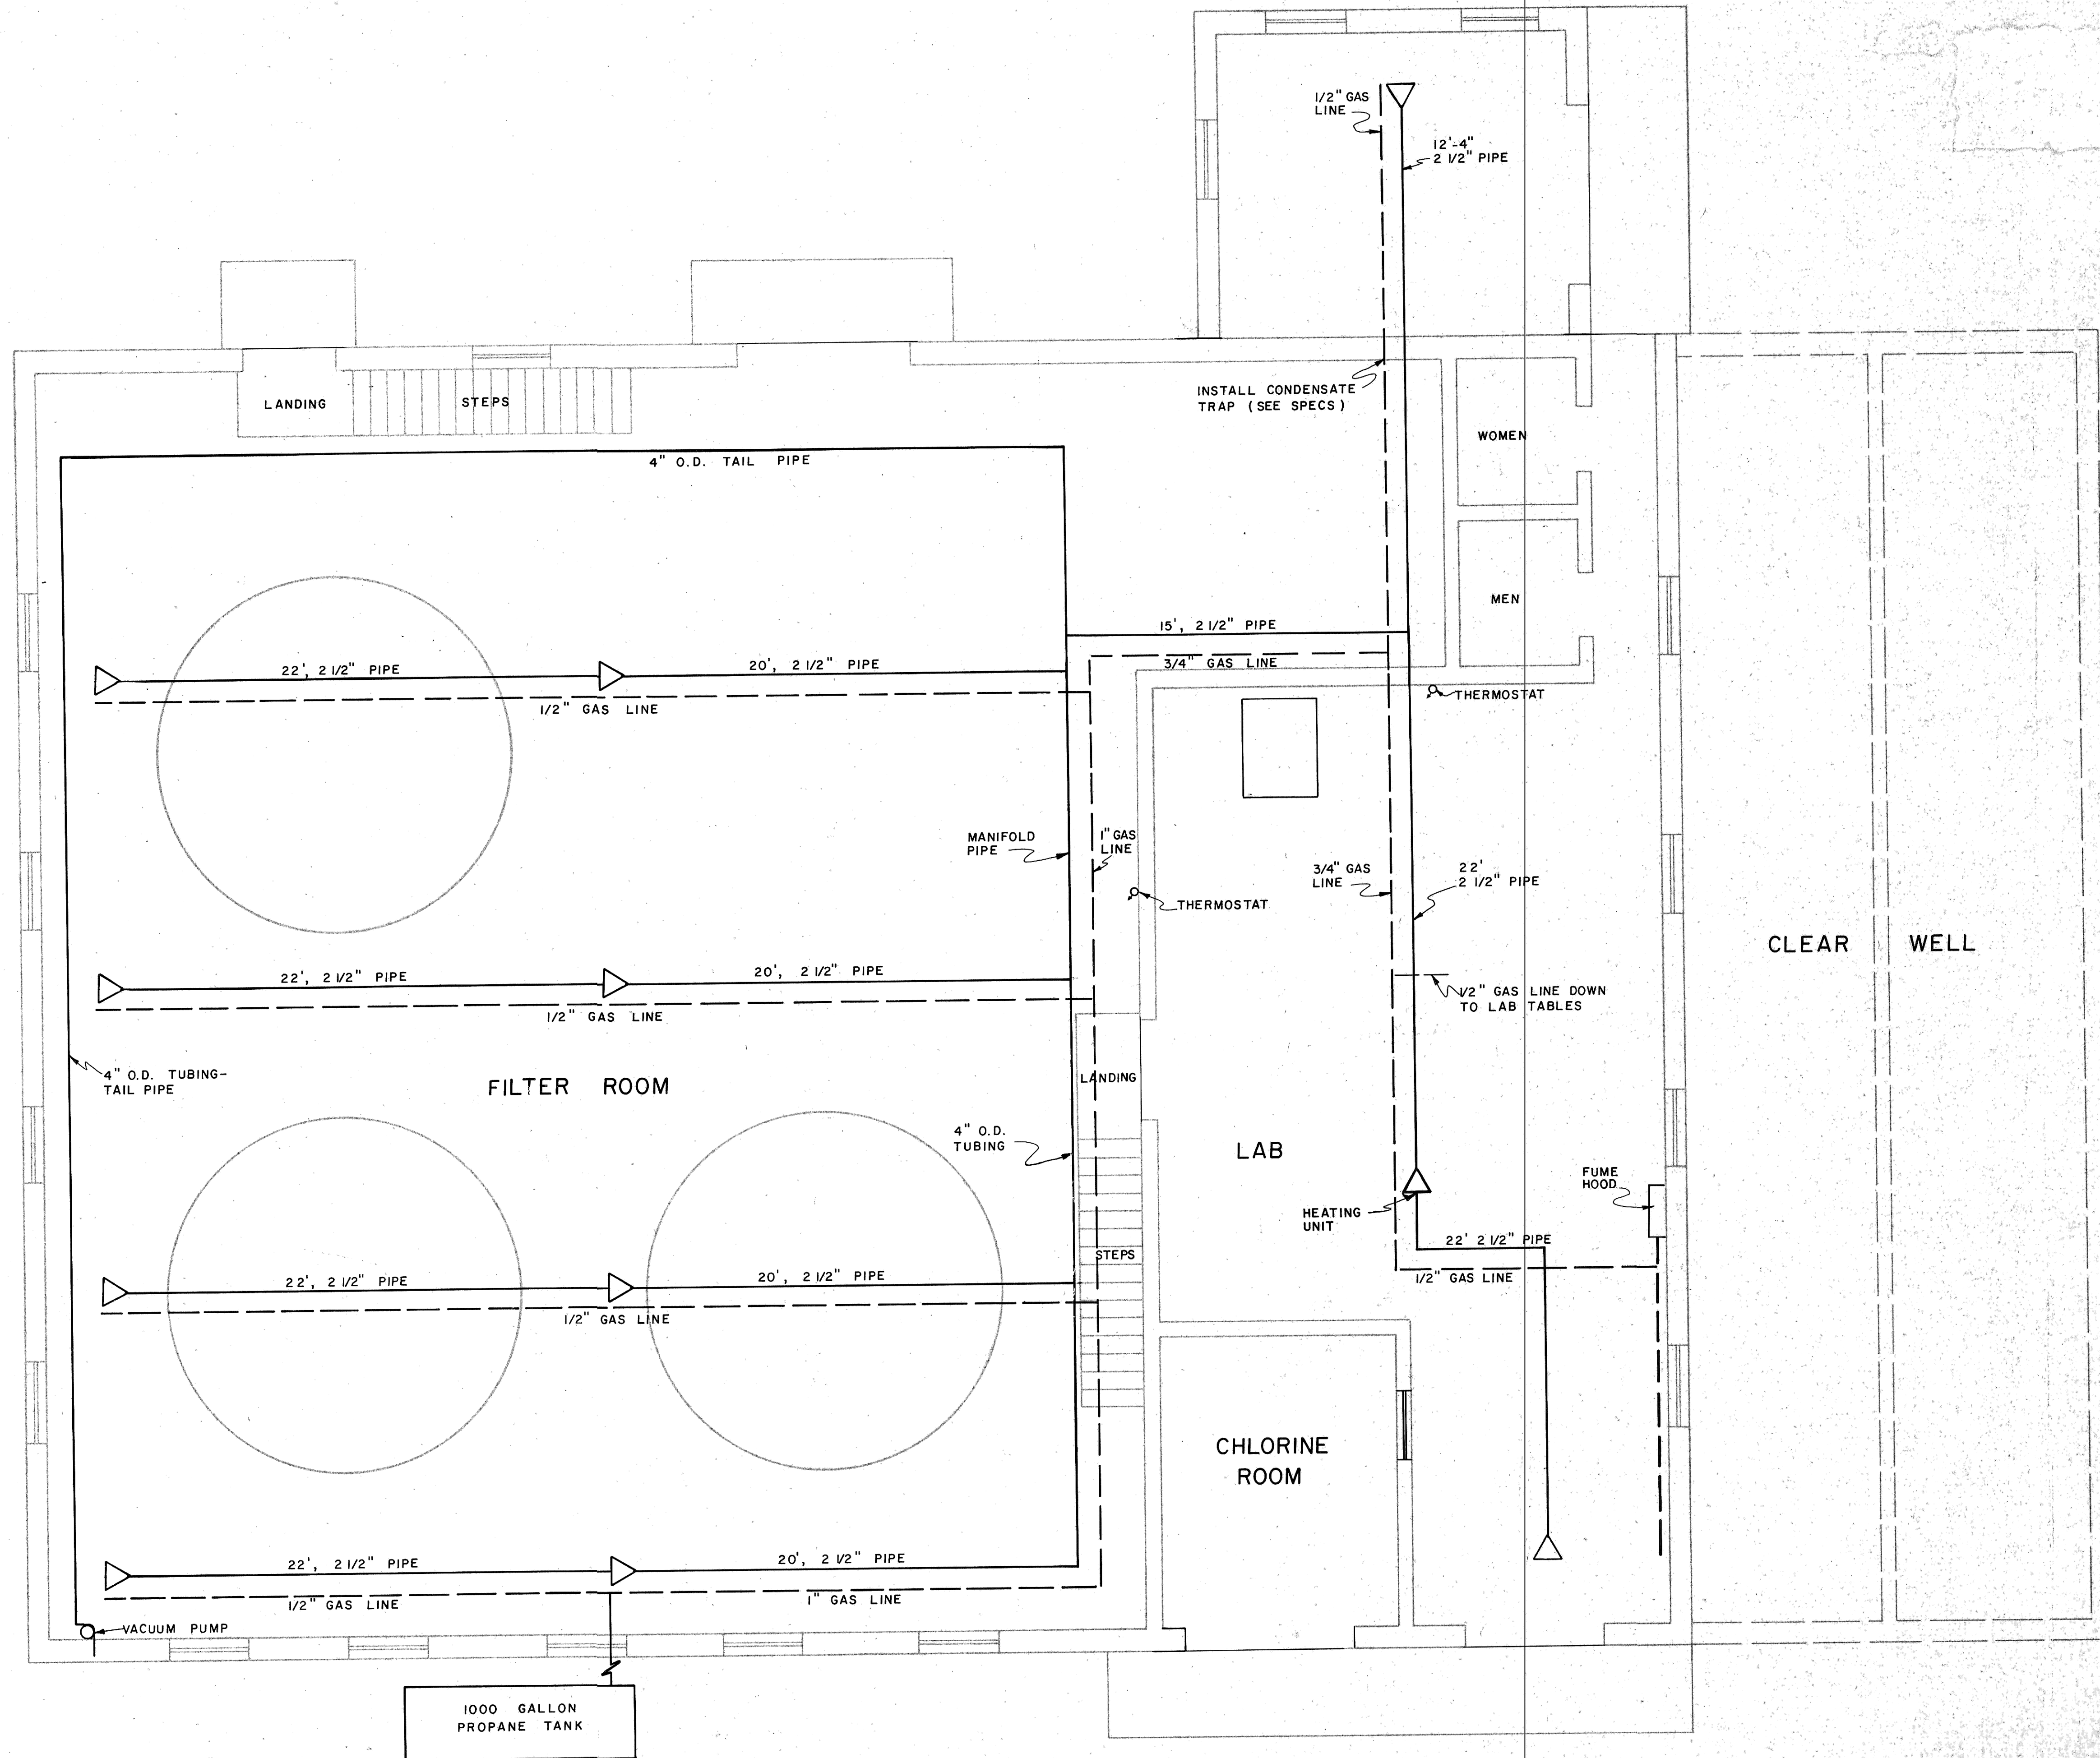

UPGRADING WASTEWATER TREATMENT FACILITIES INCREMENT 1
 CONTRACTOR'S RECORD DRAWINGS (AS BUILT)
 EPA NO. C380325-03
 CITY OF MANDAN, N.D.
 CITY PROJECT NO.-SEWER IMPROVEMENT DISTRICT NO.-17

TOMAN ENGINEERING COMPANY
 CIVIL & ENVIRONMENTAL CONSULTANTS
 P.O. BOX 708
 BOISSEVAIN, MAN. ROK OEO
 MANDAN, N.D. 58554

DATE: _____
 CHECKED BY: _____
 DRAWN BY: _____
 REVISIONS: _____

SHEET NUMBER
 5-B
 OF 23 SHEETS

HEATING LAYOUT